

ENTRANCE



KEYNOTE

PAC THEATER



POSTERS

Section A

REGISTRATION

EXHIBITORS/SPONSORS

COAT RACKS

CAFE A, B, C

Section B 200

Breakfast
Lunch
Roundtables
Afternoon Networking

EXHIBITORS/SPONSORS

NJLA STORE


Section C

LEVEL 2

MOST BREAKOUTS ON LEVEL 1

MIDDLESEX COUNTY COLLEGE
 DIVISION OF FACILITIES MANAGEMENT ENGINEERING DEPARTMENT
 2600 VANDERBURG AVE. PO BOX 3800 EDISON, NJ 08818 732-906-0611

PROJECT:	DATE: 6/02/06	SHEET NUMBER:
COLLEGE CENTER	DRAWN BY: MKK	
2nd Floor Plan	CHECKED BY: AR	
	REVISED: MKK-16	
	CAD FILED: CC-2	
	SCALE: 1/4"=1'	OF 3

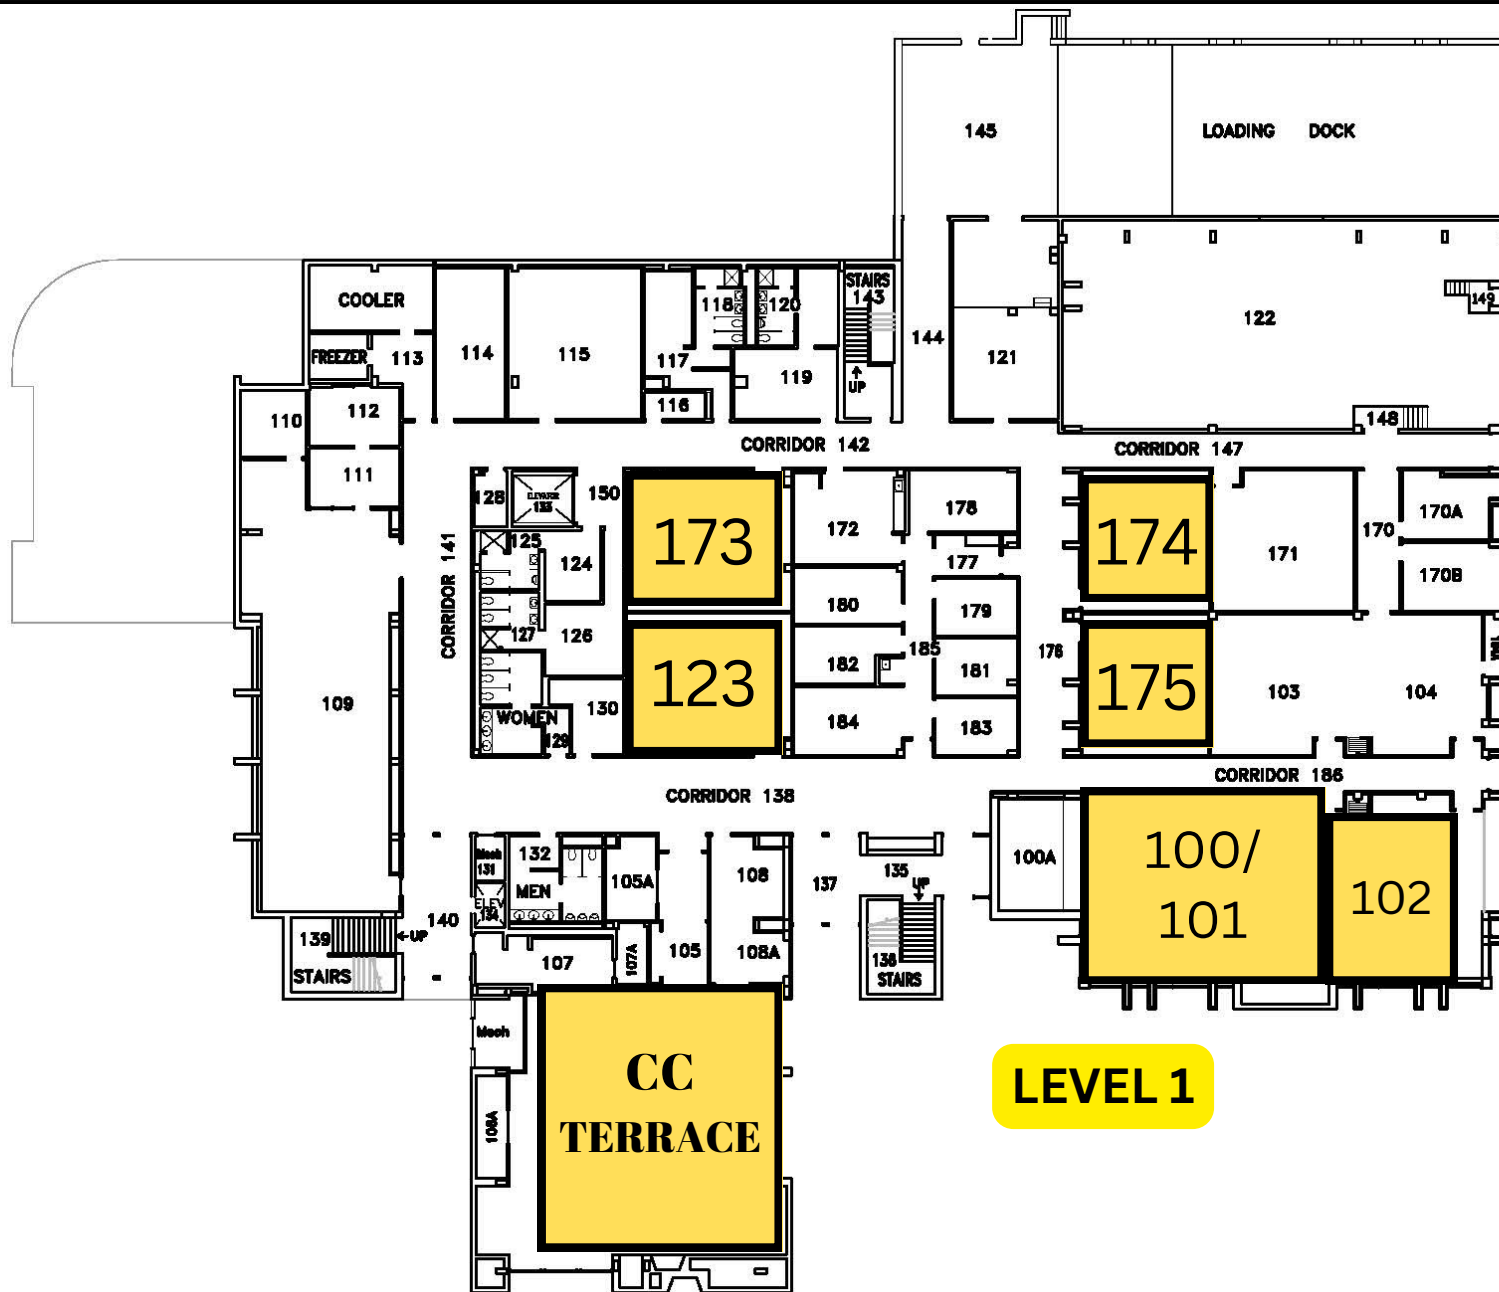

LEVEL 1

MIDDLESEX COUNTY COLLEGE
 DIVISION OF FACILITIES MANAGEMENT ENGINEERING DEPARTMENT
 2500 WOODBRIDGE AVE. PO BOX 3828 EDISON, NJ 08818-7328-2511

PROJECT:	DATE: 1/28/25	SHEET NUMBER:
COLLEGE CENTER	DRAWN BY: MKK	
1st Floor Plan	CHECKED BY: AR	
	REVISED: MKK-16	
	CAD FILED: CC-1	OF 3
	SCALE: 1/4"=1'	